


PROJECT: <b>Sample</b> 2/17/2010 2:43 AM	1	SHEET:	NAME: -	-
		DRAWN: Marcin Wolanski	DATE: -	
		REVISION: Marcin 2D_Cars	SCALE: AS NOTED	
		HOUSE STYLE: -		


**PERICO AS**

LILLEAKERVEIEN 31  
0283 OSLO, NORWAY  
www.pericosoft.com



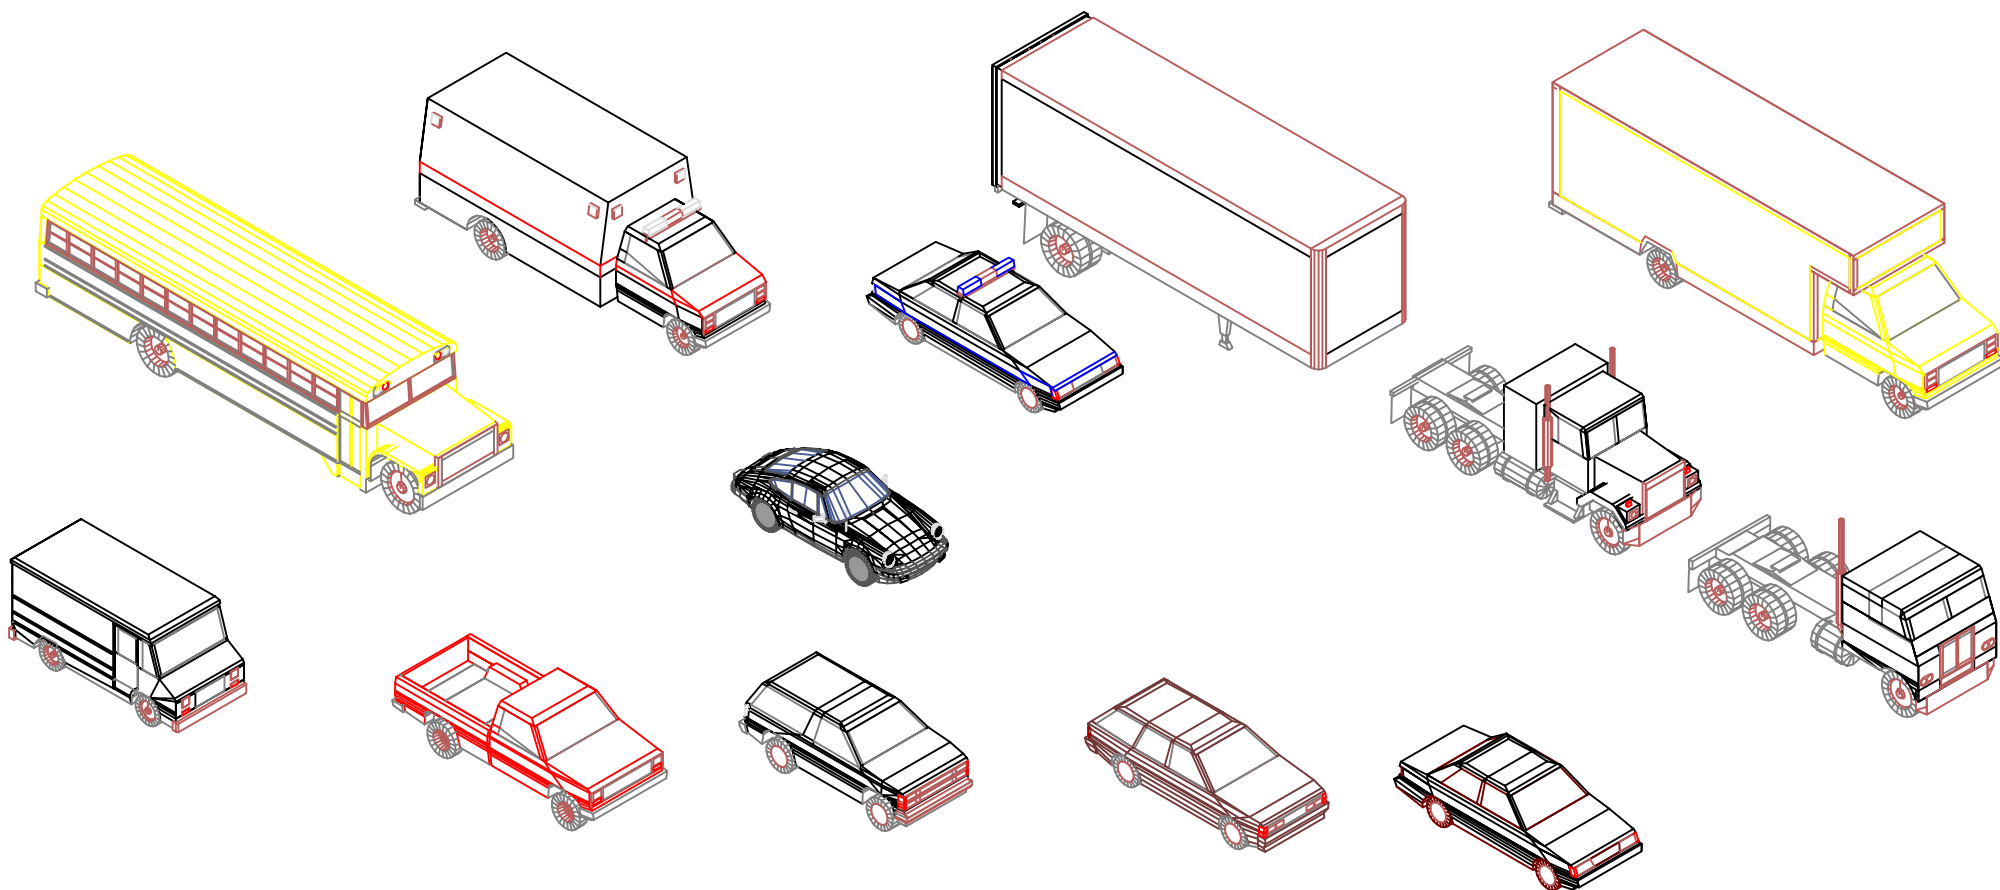

PROJECT: <b>Sample</b> 2/17/2010 3:35 AM	<b>2</b>	SHEET:		NAME: -	-
		DRAWN: Marcin Wolanski	DATE: -		
		REVISION: Marcin 3D_Cars	SCALE: AS NOTED		
		HOUSE STYLE: -			
				<b>PERICO AS</b> LILLEAKERVEIEN 31 0283 OSLO, NORWAY <a href="http://www.pericosoft.com">www.pericosoft.com</a>	



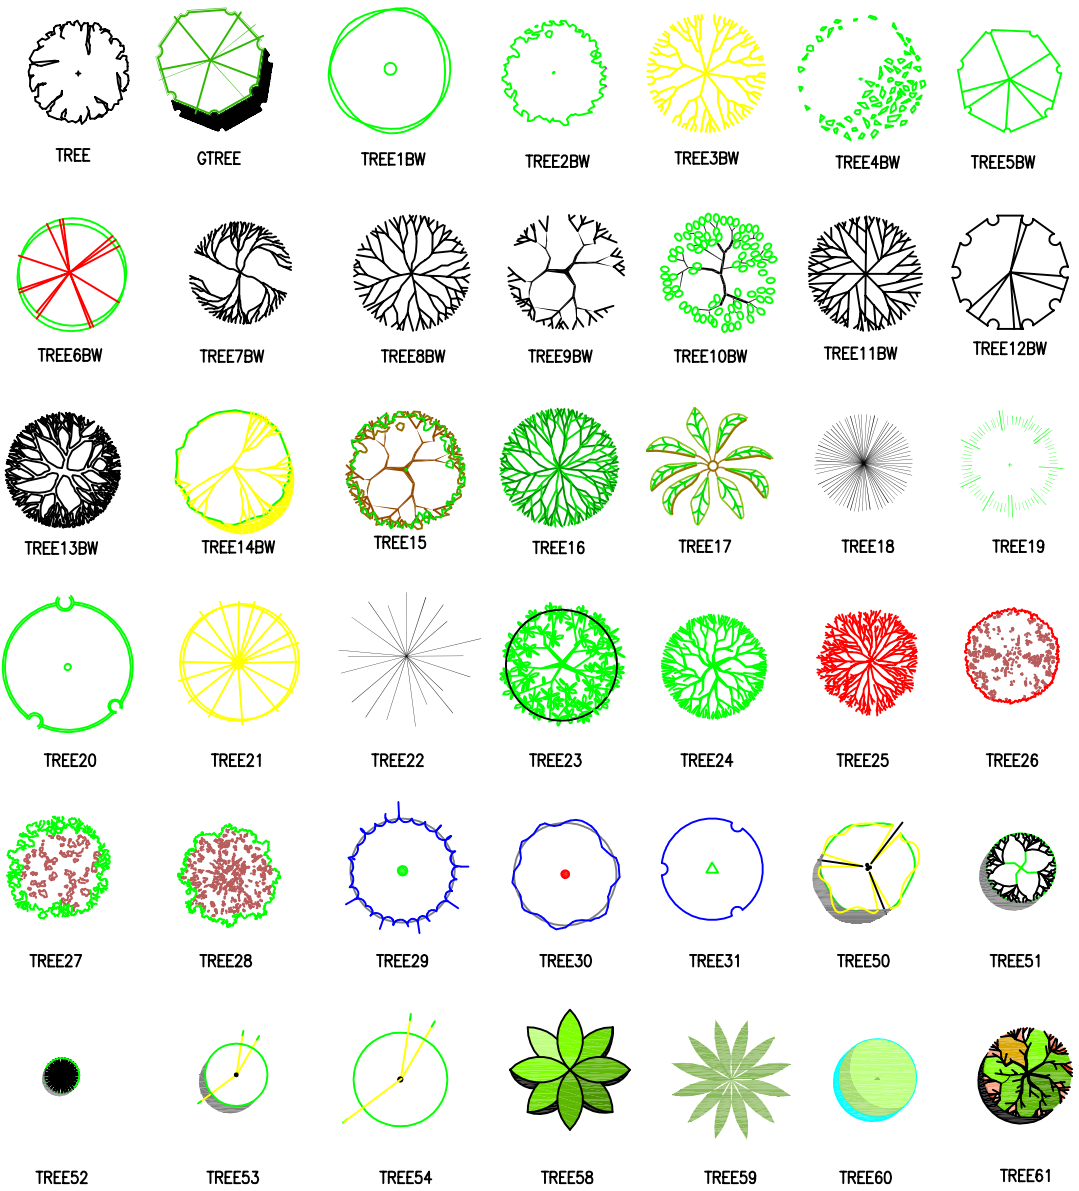



PROJECT: <b>Sample</b> 2/11/2010 9:15 AM	<b>3</b>	SHEET:		NAME: -
		DRAWN: Marcin Wolanski	DATE: -	
		REVISION: Marcin 2D_Trees	SCALE: AS NOTED	
		HOUSE STYLE: -		

**PERICO AS**

LILLEAKERVEIEN 31  
0283 OSLO, NORWAY  
www.pericosoft.com



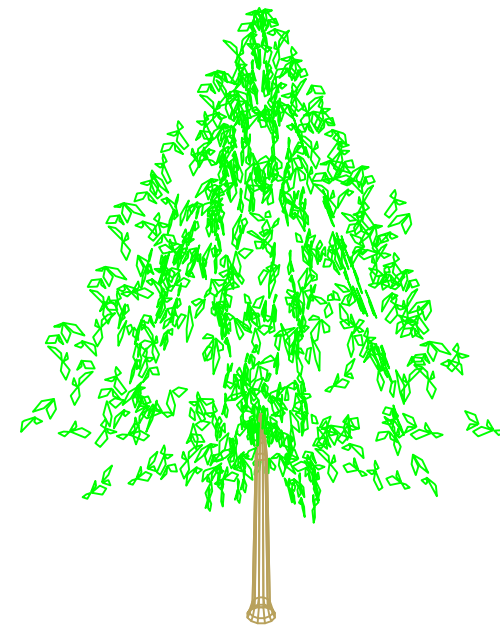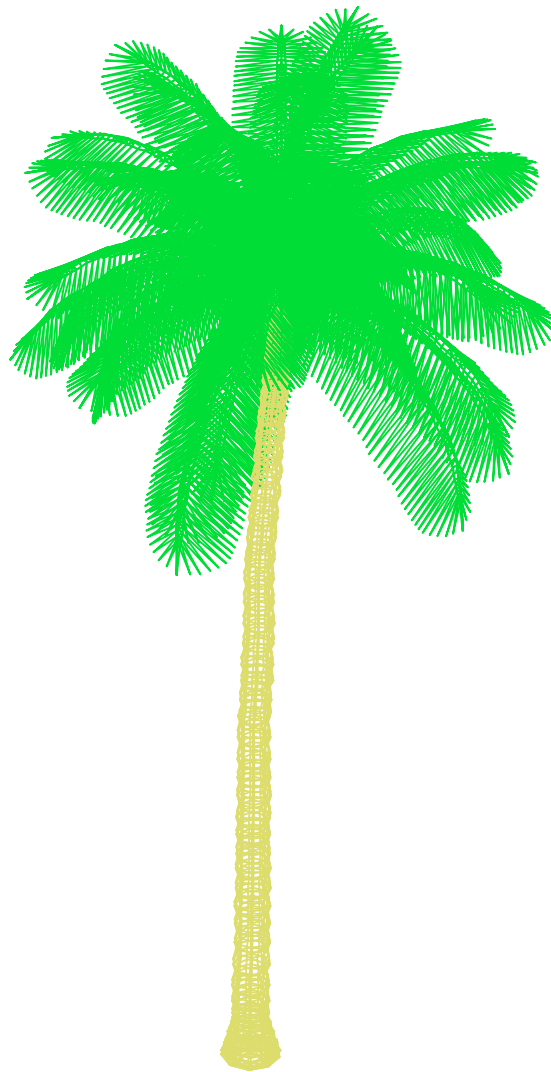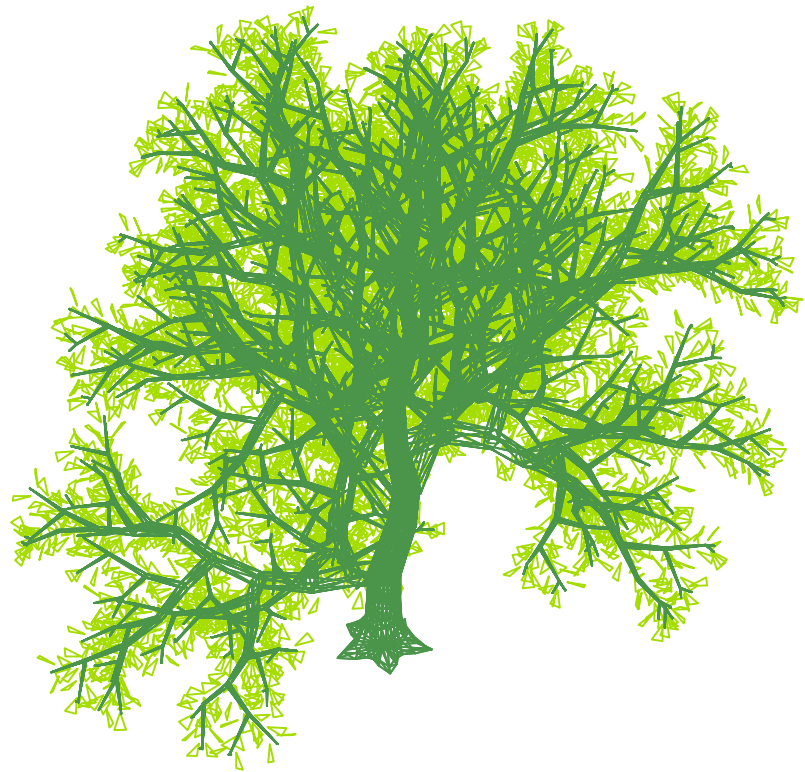

<b>PROJECT:</b> <b>Sample</b> 2/10/2010 12:36 PM	<b>SHEET:</b> <b>4</b>	NAME: -	-
		DRAWN: Marcin Wolanski	DATE: -
		REVISION: Marcin 3D_Trees	SCALE: AS NOTED
		HOUSE STYLE: -	-
		<b>PERICO AS</b> LILLEAKERVEIEN 31 0283 OSLO, NORWAY www.pericosoft.com	



PROJECT: <b>Sample</b> 2/17/2010 4:52 AM	<b>5</b>	SHEET:	NAME:	-	
		DRAWN:	Marcin Wolanski	DATE:	-
		REVISION:	Marcin Elevation & Floor Plan Samples	SCALE:	AS NOTED
		HOUSE STYLE:	-		

**PERICO AS**

LILLEAKERVEIEN 31  
0283 OSLO, NORWAY  
www.pericosoft.com



**ANCILLARY EQUIPMENT**

- IMPULSE CLOCK - MASTER.
- IMPULSE CLOCK - SLAVE.
- BATTERY OR MAINS OPERATED CLOCK.
- FAN REGULATOR.
- CEILING FAN.
- WALL MOUNTED FAN.
- TRANSFORMER.  
?"Y" DENOTES SECONDARY VOLTAGE.
- TUBULAR HEATER.  
?"W" DENOTES RATING (KW).  
GENERAL SYMBOL WITH ATTRIBUTABLE TEXT.  
e.g., "IN USE" SIGN.
- T.V. MONITOR.

**COMMUNICATIONS**

- TELEPHONE OUTLET - TYPE 1.
- TELEPHONE OUTLET - TYPE 2.
- VIDEO INTERCOM/ DOOR ENTRY UNIT.
- INTERCOM OUTLET.
- FIRE TELEPHONE OUTLET.
- TV/FM DUAL OUTLET.
- DATA OUTLET - TYPE 1.
- DATA OUTLET - TYPE 2.  
?"?" DENOTES TYPE.
- PUBLIC ADDRESS SPEAKER.  
?"?" DENOTES TYPE.
- VOICE ALARM.
- PUBLIC ADDRESS VOLUME CONTROL.
- PUBLIC ADDRESS VOICE SWITCH. (MUTE)
- TELECOM BACK BOX.
- ELY DOOR BELL C/W TRANSFORMER.
- AERIAL - UHF/ VHF TV.
- AERIAL - FM/ VHF RADIO.
- AERIAL - FM/ VHF RADIO.
- AMPLIFIER.  
?"?" DENOTES TYPE.
- FLOOR MOUNTED TELEPHONE OUTLET - TYPE 1.
- FLOOR MOUNTED TELEPHONE OUTLET - TYPE 2.
- TELEPHONE JUNCTION BOX.
- VIDEO PHONE CONTROL PANEL.  
"???" DENOTES PANEL REFERENCE.
- TELEPHONE JUNCTION BOX.
- EMERGENCY CALL BUTTON.
- DISABLED ALARM.
- DISABLED ALARM POWER SUPPLY UNIT.
- DISABLED ALARM RESET.
- DISABLED ALARM PULL CORD.
- MUSIC LINE INPUT POINT. (JACK PLUG)

**FIRE ALARM**

- SMOKE SENSOR.
- HEAT SENSOR.
- TOWN GAS SENSOR.
- ELECTROMAGNETIC DOOR HOLDER.
- BELL.
- BUZZER.
- SIREN - CEILING MOUNTED.
- SIREN - WALL MOUNTED.
- REMOTE INDICATOR LAMP.
- XENON FLASHER/ STROBE LIGHT.

- MAIN FIRE ALARM PANEL.
- M/M/C FIRE INDICATOR PANEL.
- REPEAT FIRE ALARM PANEL.
- FIRE ALARM INTERFACE UNIT.
- EXTINGUISHING GAS WARNING LAMPS.
- CARBON DIOXIDE WARNING LAMPS.
- BREAK GLASS UNIT - TYPE 1

**INDUSTRIAL PLUGS & SOCKETS**

- WALL MOUNTED TRANSFORMER.  
?"V" DENOTES VOLTAGE RATING.  
?"VA" DENOTES VOLT AMP RATING.  
?"P&N" DENOTES SINGLE OR THREE PHASE.
- 240/415V SWITCHED SOCKET OUTLET  
?"P&N" DENOTES SINGLE OR THREE PHASE.  
?"V" DENOTES VOLT AMP RATING.  
?"W" DENOTES WATERPROOF  
?"N" DENOTES SINGLE OR TWIN UNIT

**110V SWITCHED SOCKET OUTLET**

- 110V SWITCHED SOCKET OUTLET  
?"VA" DENOTES VOLT AMP RATING.  
?"W" DENOTES WATERPROOF  
?"N" DENOTES SINGLE OR TWIN

**LIGHTING**

- SURFACE OR RECESSED LUMINAIRE.
- WALL MOUNTED LUMINAIRE.
- PENDANT LUMINAIRE.
- TRACK MOUNTED LUMINAIRE.
- 600mm SINGLE LAMP SURFACE MOUNTED LUMINAIRE.
- 900mm SINGLE LAMP SURFACE MOUNTED LUMINAIRE.
- 1200mm SINGLE LAMP SURFACE MOUNTED LUMINAIRE.
- 1500mm SINGLE LAMP SURFACE MOUNTED LUMINAIRE.
- 600mm SINGLE LAMP WALL MOUNTED LUMINAIRE.
- 1200mm SINGLE LAMP WALL MOUNTED LUMINAIRE.
- 1500mm SINGLE LAMP WALL MOUNTED LUMINAIRE.
- 1200mm TWIN LAMP SURFACE MOUNTED LUMINAIRE.
- 1500mm TWIN LAMP SURFACE MOUNTED LUMINAIRE.
- 1800mm TWIN LAMP SURFACE MOUNTED LUMINAIRE.
- 1200mm TWIN LAMP WALL MOUNTED LUMINAIRE.
- 1500mm TWIN LAMP WALL MOUNTED LUMINAIRE.
- 1200mm SINGLE LAMP RECESSED LUMINAIRE.
- 1500mm SINGLE LAMP RECESSED LUMINAIRE.
- 1200mm TWIN LAMP RECESSED LUMINAIRE.
- 1500mm TWIN LAMP RECESSED LUMINAIRE.
- 1200mm THREE OR FOUR LAMP RECESSED LUMINAIRE.
- 1500mm THREE OR FOUR LAMP RECESSED LUMINAIRE.
- 1550x400 RECESSED LUMINAIRE.
- 600x600 RECESSED LUMINAIRE.
- 500x500 RECESSED LUMINAIRE.
- 300x300 RECESSED LUMINAIRE.
- LINEAR FLUORESCENT LUMINAIRE.

- EMERGENCY BULKHEAD/ EXIT SIGN LUMINAIRE.
- EMERGENCY EXIT SIGN LUMINAIRE. (DIRECTIONAL)
- EMERGENCY EXIT SIGN LUMINAIRE. (DIRECTIONAL)

- EMERGENCY EXIT SIGN LUMINAIRE. (DIRECTIONAL).
- PASSIVE INFRA-RED MOTION DETECTOR.
- PHOTOCELL.
- DIMMING PANEL (D/M) OR GROUP CONTROL PANEL (GCP) AS APPLICABLE.
- LIGHTING CONTROL.
- AREA CONTROLLER.
- LIGHTING CONTACTOR.
- MARSHALLING BOX.
- LIGHTING TRANSFORMER.
- FLAME PROOF SWITCH. (APPROPRIATE SWITCH TO BE INSERTED INTO BOX)
- SELF CONTAINED EMERGENCY BEAM LIGHT UNIT.
- LIGHTING TRACK WITH SPOTLIGHT.
- BOLLARD.
- ?"?" DENOTES REF. TYPE.
- FLOOR GRONOMMET.
- HIGH BAY.  
?"?" DENOTES REF. TYPE.
- LIGHTING CONTROL CONTACTOR & TIME SWITCH.
- LIGHTING DISTRIBUTION BOX.
- 2 WAY FLOOD.
- WALLWASHER LUMINAIRE

- 1 WAY SWITCH.
- 2 WAY SWITCH.
- DOUBLE POLE SWITCH.
- 1 WAY KEYSWITCH.
- 1 WAY WEATHERPROOF SWITCH.
- DIMMER SWITCH.
- INTERMEDIATE SWITCH.
- 1 WAY CEILING SWITCH.
- CLOSET LIGHTING SWITCH.
- LIGHTING MANAGEMENT SWITCH

**LIGHTNING PROTECTION**

- EARTH PIT.
- EARTH BUILDING CONNECTION.
- EARTH BOND.
- LIGHTNING PROTECTION AIR TERMINATION FINAL POINT.
- LIGHTNING PROTECTION 25x3mm AIR TERMINATOR NETWORK.
- EARTH TEST PIT.
- VERTICAL TAPE.
- SINGLE PHASE INDICATING LAMP.

**SCHEMATIC**

- THREE PHASE INDICATING LAMPS
- MEASUREMENT CURRENT TRANSFORMER.  
?"S" DENOTES COIL RATIO.
- PROTECTION CURRENT TRANSFORMER.  
?"S" DENOTES COIL RATIO.
- VOLTAGE TRANSFORMER.  
?"S" DENOTES COIL RATIO.
- OVER CURRENT PROTECTION RELAY.
- EARTH FAULT PROTECTION RELAY.
- UNDER VOLTAGE PROTECTION RELAY.
- PHASE FAILURE RELAY.
- RESTRICTIVE EARTH FAULT RELAY.

- SELECTOR SWITCH.
- TIME SWITCH/ WITH MANUAL BYPASS.
- POWER FACTOR METER.
- AMMETER.
- VOLTMETER.
- KILOWATT METER.
- MAXIMUM DEMAND METER.
- REACTIVE POWER METER.
- SUPPLY AUTHORITIES METER (KWH).
- CHECK METER (KWH).
- ANALOGUE METER WITH SELECTOR SWITCH.

- DIGITAL METER  
kWhr = KILOWATT HOUR  
V = VOLTS  
A = AMPS  
PF = POWER FACTOR  
kW = KILOWATT  
kVA = KILOWOLTS AMP REACTIVE  
kVA = KILOWOLT AMPS  
??? = MCT, PCT OR VT  
-- = RATIO

- SUPPLY AUTHORITY METER.
- GENERATOR.
- DIRECT-ON-LINE STARTER.
- STAR-DELTA STARTER.
- AUTO-TRANSFORMER STARTER.
- MOTOR.
- CABLE LINK BOX.  
?"?" DENOTES RATING (AMPS).
- CABLE DRAW PIT.  
?"?" DENOTES SIZE.
- EARTH TERMINAL.
- BUSBAR CHAMBER.  
?"?" DENOTES RATING (AMPS).
- RESIDUAL CURRENT DEVICE.  
?"?" DENOTES SENSITIVITY (MILLI AMPS).
- TAP OFF UNIT.  
?"?" DENOTES RATING (AMPS).
- CONTACTOR.  
?"A" DENOTES RATING (AMPS).  
?"P" DENOTES No. OF POLES.
- BATTERY CHARGER.  
?"A" DENOTES AMPERE HOURS.
- "C" DENOTES ASCO SWITCH (CONTACTOR).  
?"??" DENOTES DISTRIBUTION REF.
- AUTOMATIC CHANGE-OVER SWITCH.
- CABLE REFERENCE.
- EARTH CABLE REFERENCE.
- DELTA/ DELTA TRANSFORMER.  
?"kVA" DENOTES RATING (KILOWOLT AMPS).  
?"V" DENOTES PRIMARY AND SECONDARY VOLTAGES.
- STAR/ DELTA TRANSFORMER.  
?"kVA" DENOTES RATING (KILOWOLT AMPS).  
?"V" DENOTES PRIMARY AND SECONDARY VOLTAGES.
- STAR/ STAR TRANSFORMER.  
?"kVA" DENOTES RATING (KILOWOLT AMPS).  
?"V" DENOTES PRIMARY AND SECONDARY VOLTAGES.

- FUSED SWITCH.  
?"A" DENOTES FUSE RATING (AMPS).  
?"A" DENOTES FRAME SIZE (AMPS).  
?"P&N" DENOTES No. OF POLES.
- SWITCH FUSED.  
?"A" DENOTES FUSE RATING (AMPS).  
?"A" DENOTES DEVICE RATING (AMPS).  
?"P&N" DENOTES No. OF POLES.

- ISOLATING SWITCH.  
?"A" DENOTES RATING (AMPS).  
?"P" DENOTES No. OF POLES.

- HRC FUSE.  
?"A" DENOTES RATING (AMPS).  
?"P" DENOTES No. OF POLES.

- SOLID COPPER LINK.

- NEUTRAL LINK.  
?"A" DENOTES DEVICE SETTING (AMPS).  
?"A" FRAME SIZE (AMPS).  
?"CB" DENOTES MCB OR MCCB. (BREAKER TYPE).  
?"P&N" DENOTES No. OF POLES. INDICATES NON AUTO.

- RISING BUSBAR TAP OFF  
?"A" DENOTES PROTECTION RATING (AMPS).  
?"A" DENOTES EQUIPMENT RATING (AMPS).  
?"P&N" DENOTES No. OF POLES.

- 45 AMP DOUBLE POLE SWITCH C/W NEON INDICATOR. "W" DENOTES WATER HEATER.  
?"A" DENOTES DEVICE SETTING (AMPS).  
?"A" FRAME SIZE (AMPS).  
?"CB" DENOTES ACB OR VCB OR OCB. (BREAKER TYPE)  
?"P&N" DENOTES No. OF POLES.

- SOCKET OUTLET FOR HAZARDOUS AREAS.  
?"A" DENOTES RATING (AMPS).  
?"P&N" DENOTES No. OF POLES.

- SOCKET OUTLET FOR HAZARDOUS AREAS.  
?"A" DENOTES RATING (AMPS).  
?"P&N" DENOTES No. OF POLES.

**SECURITY SYSTEM**

- SECURITY - DOOR CONTACT.
- SECURITY - SHUNT KEY SWITCH.
- SECURITY - KICK BAR.
- SECURITY - WATCHMAN TOUR STATION.
- SECURITY - PANIC/ RAID ATTACK SWITCH.
- SECURITY - ELECTRICALLY OPERATED LOCK.
- SECURITY - MANUAL LOCK.
- SECURITY - PASSIVE INFRARED DETECTOR.
- SECURITY - PASSIVE INFRARED DETECTOR 360.
- SECURITY - CARD/ DIGITAL ACCESS CONTROL UNIT.
- SECURITY - KEYPAD ACCESS CONTROL UNIT.
- SECURITY - KEYPAD ACCESS CONTROL UNIT. (SCHEMATIC)
- SECURITY - VIBRATION DETECTOR.
- SECURITY - PERSONNEL ATTACK.
- SECURITY - BREAK GLASS DETECTION.
- SECURITY - EMERGENCY DOOR RELEASE BREAK GLASS UNIT & REQUEST TO EXIT PUSH.
- SECURITY - CCTV CAMERA.  
?"?" DENOTES TYPE.
- GLOBE TYPE CCTV CAMERA.
- DOOR RELEASE BUTTON.
- AUDIO VISUAL.
- SECURITY AREA CONTROL PANEL.

**SMALL POWER**

- SOCKET OUTLET.
- TWIN SOCKET OUTLET.
- SWITCHED SOCKET OUTLET.
- TWIN SWITCHED SOCKET OUTLET.
- FUSED CONNECTION UNIT.
- FUSED CONNECTION UNIT C/W NEON.
- SWITCHED FUSE CONNECTION UNIT.
- SWITCHED FUSE CONNECTION UNIT C/W NEON.
- SHAVER OUTLET.
- SWITCHED SOCKET OUTLET - RCD PROTECTED.
- SOCKET OUTLET.
- FLOOR MOUNTED SOCKET OUTLET.
- TWIN FLOOR MOUNTED SOCKET OUTLET.
- NON STANDARD SOCKET OUTLET.
- FLOOR BOX WITH REF. No.

- 45 AMP DOUBLE POLE SWITCH C/W NEON INDICATOR. "C" DENOTES COOKER.

- 45 AMP DOUBLE POLE SWITCH C/W NEON INDICATOR. "C" DENOTES COOKER.

- 45 AMP DOUBLE POLE SWITCH C/W NEON INDICATOR. "W" DENOTES WATER HEATER.

- SOCKET OUTLET FOR HAZARDOUS AREAS.  
?"A" DENOTES RATING (AMPS).  
?"P&N" DENOTES No. OF POLES.

- BUS BAR.  
?"?" INDICATES No. OF BARS  
4 BARS INDICATES CLEAN EARTH  
"A" INDICATES RATINGS (AMPS).

- CLEAN EARTH BAR.

- EARTH BAR.

- ISOLATOR  
?"A" DENOTES RATING (AMPS)  
?"P&N" DENOTES POLES.

- FUSED SWITCH  
?"A" DENOTES RATING (AMPS)  
?"P" DENOTES POLES.

- DISTRIBUTION BOARD REF TO INDICATE CIRCUITS.

- MOTOR CONTROL CENTRE.

- EMERGENCY POWER OFF/ STOP LOCK BUTTON.

- JUNCTION BOX.
- SMALL POWER CONTACTOR.
- CONTROL PANEL.


PROJECT: **Sample**  
2/18/2010 3:10 AM

SHEET: **6**

NAME:	-	DATE:	-
DRAWN:	Marcin Wolanski	SCALE:	AS NOTED
REVISION:	Marcin Electrical Symbols		
HOUSE STYLE:	-		

**PERICO AS**  
LILLEAKERVEIEN 31  
0283 OSLO, NORWAY  
www.pericosoft.com



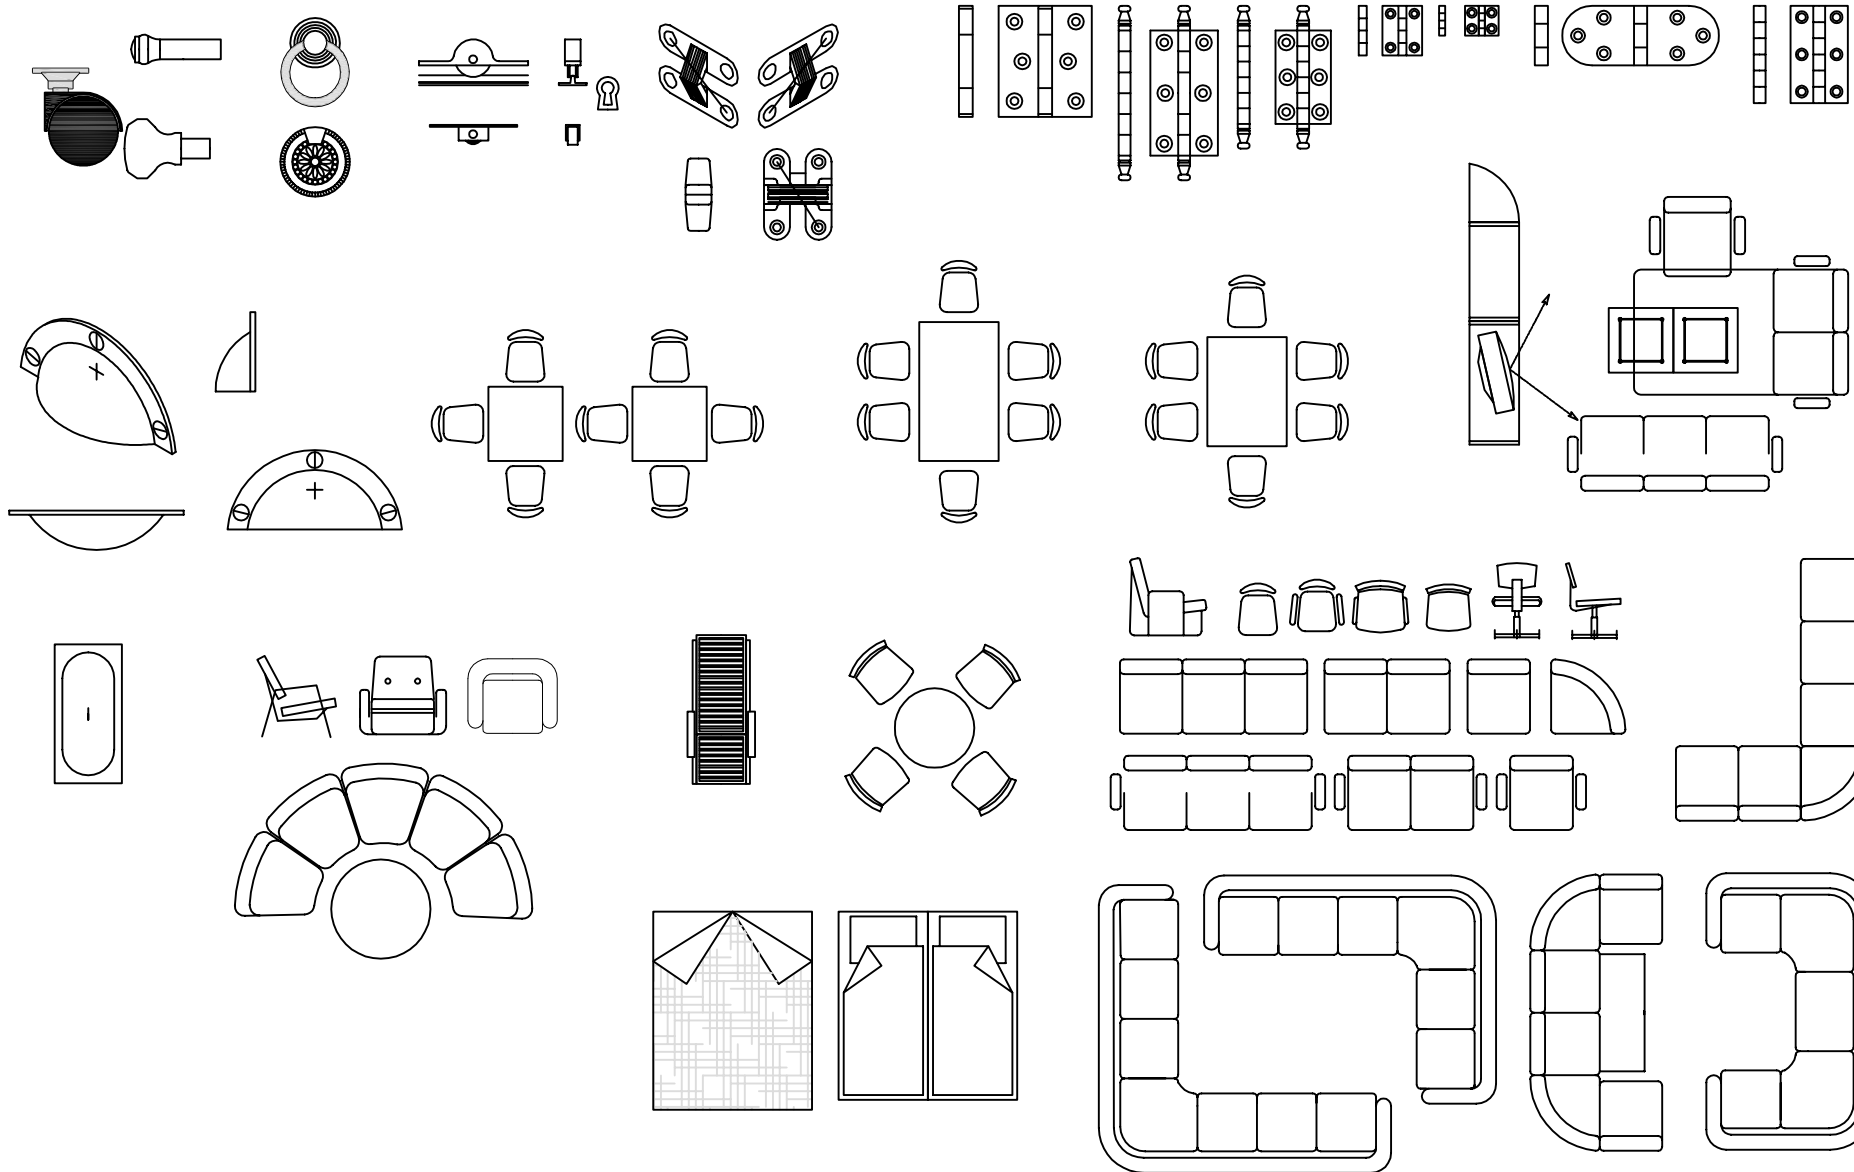



PROJECT: <b>Sample</b> <small>2/18/2010 3:22 AM</small>	SHEET: <b>7</b>	NAME: -	-
		DRAWN: Marcin Wolanski	DATE: -
		REVISION: Marcin Furniture Symbols	SCALE: AS NOTED
		HOUSE STYLE: -	-

**PERICO AS**


LILLEAKERVEIEN 31  
 0283 OSLO, NORWAY  
[www.pericosoft.com](http://www.pericosoft.com)






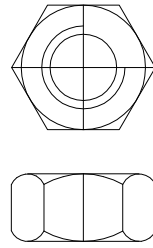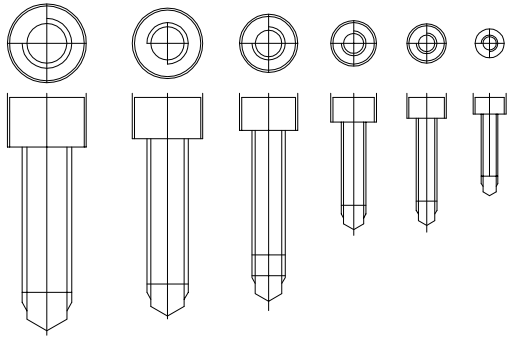


M20

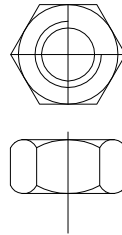


M16

 


M12

 


M10

 

M8

 




M6

 

M5



   M4



1/8"	1/4"	3/8"	1/2"	3/4"	1"	1-1/8"	1-1/4"	1-3/8"	1-1/2"	1-3/4"	2"	2-1/4"	2-1/2"	2-3/4"	3"	3-1/4"	3-1/2"	3-3/4"	4"	
[Symbol]	[Symbol]	[Symbol]	[Symbol]	[Symbol]	[Symbol]	[Symbol]	[Symbol]	[Symbol]	[Symbol]	[Symbol]	[Symbol]	[Symbol]	[Symbol]	[Symbol]	[Symbol]	[Symbol]	[Symbol]	[Symbol]	[Symbol]	[Symbol]
[Symbol]	[Symbol]	[Symbol]	[Symbol]	[Symbol]	[Symbol]	[Symbol]	[Symbol]	[Symbol]	[Symbol]	[Symbol]	[Symbol]	[Symbol]	[Symbol]	[Symbol]	[Symbol]	[Symbol]	[Symbol]	[Symbol]	[Symbol]	[Symbol]
[Symbol]	[Symbol]	[Symbol]	[Symbol]	[Symbol]	[Symbol]	[Symbol]	[Symbol]	[Symbol]	[Symbol]	[Symbol]	[Symbol]	[Symbol]	[Symbol]	[Symbol]	[Symbol]	[Symbol]	[Symbol]	[Symbol]	[Symbol]	[Symbol]
[Symbol]	[Symbol]	[Symbol]	[Symbol]	[Symbol]	[Symbol]	[Symbol]	[Symbol]	[Symbol]	[Symbol]	[Symbol]	[Symbol]	[Symbol]	[Symbol]	[Symbol]	[Symbol]	[Symbol]	[Symbol]	[Symbol]	[Symbol]	[Symbol]


4-1/4"	4-1/2"	4-3/4"	5"	5-1/4"	5-1/2"	5-3/4"	6"
[Symbol]	[Symbol]	[Symbol]	[Symbol]	[Symbol]	[Symbol]	[Symbol]	[Symbol]
[Symbol]	[Symbol]	[Symbol]	[Symbol]	[Symbol]	[Symbol]	[Symbol]	[Symbol]

[Symbol]	[Symbol]	[Symbol]	[Symbol]	[Symbol]
1-4NUT	5-16NUT	3-8NUT	7-16NUT	1-2NUT
[Symbol]	[Symbol]	[Symbol]	[Symbol]	[Symbol]
9-16NUT	5-8NUT	3-4NUT	7-8NUT	11NUT

PROJECT: <b>Sample</b> 2/18/2010 3:54 AM	SHEET: <b>9</b>	NAME: -	-
		DRAWN: Marcin Wolanski	DATE: -
		REVISION: Marcin Mechanical Symbols	SCALE: AS NOTED
		HOUSE STYLE: -	-

**PERICO AS**  
 LILLEAKERVEIEN 31  
 0283 OSLO, NORWAY  
 www.pericosoft.com



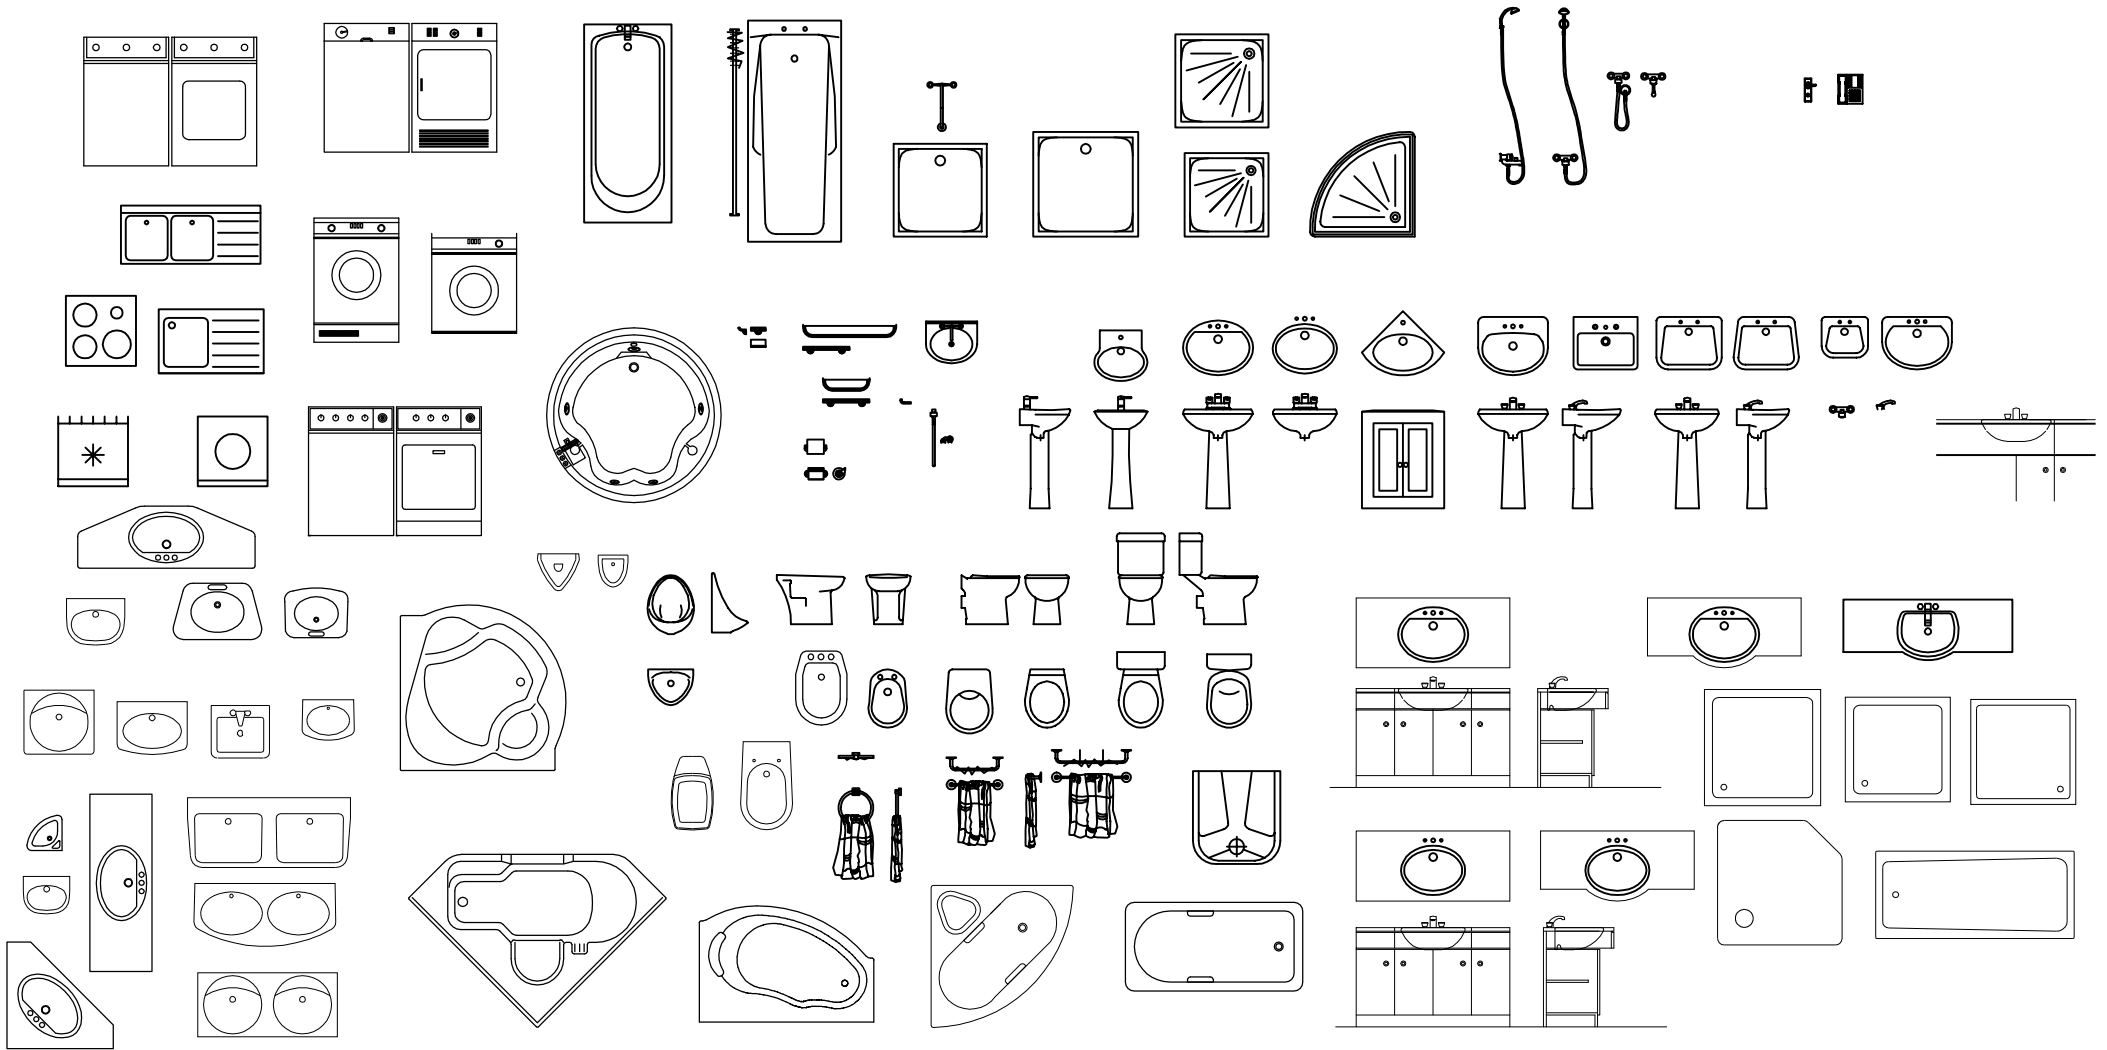

PROJECT: <b>Sample</b> <small>2/18/2010 3:43 AM</small>	SHEET: <b>10</b>	NAME: -	-
		DRAWN: Marcin Wolanski	DATE: -
		REVISION: Marcin Plumbing Symbols	SCALE: AS NOTED
		HOUSE STYLE: -	-

**PERICO AS**

LILLEAKERVEIEN 31  
 0283 OSLO, NORWAY  
[www.pericosoft.com](http://www.pericosoft.com)

